


NO SIGNIFICANT OR RISIDUAL RISKS IDENTIFIED

- General Notes:
- The drawing does not necessarily show all the information needed to interpret the design intent or the construction details.
 - The drawing contains information from more than one source and must be read in conjunction with all relevant specifications.
 - Any apparent drafting errors and differences between other drawings and specifications shall be brought to our attention.

- Project Notes:
- Refer to luminaire schedule for details of fittings

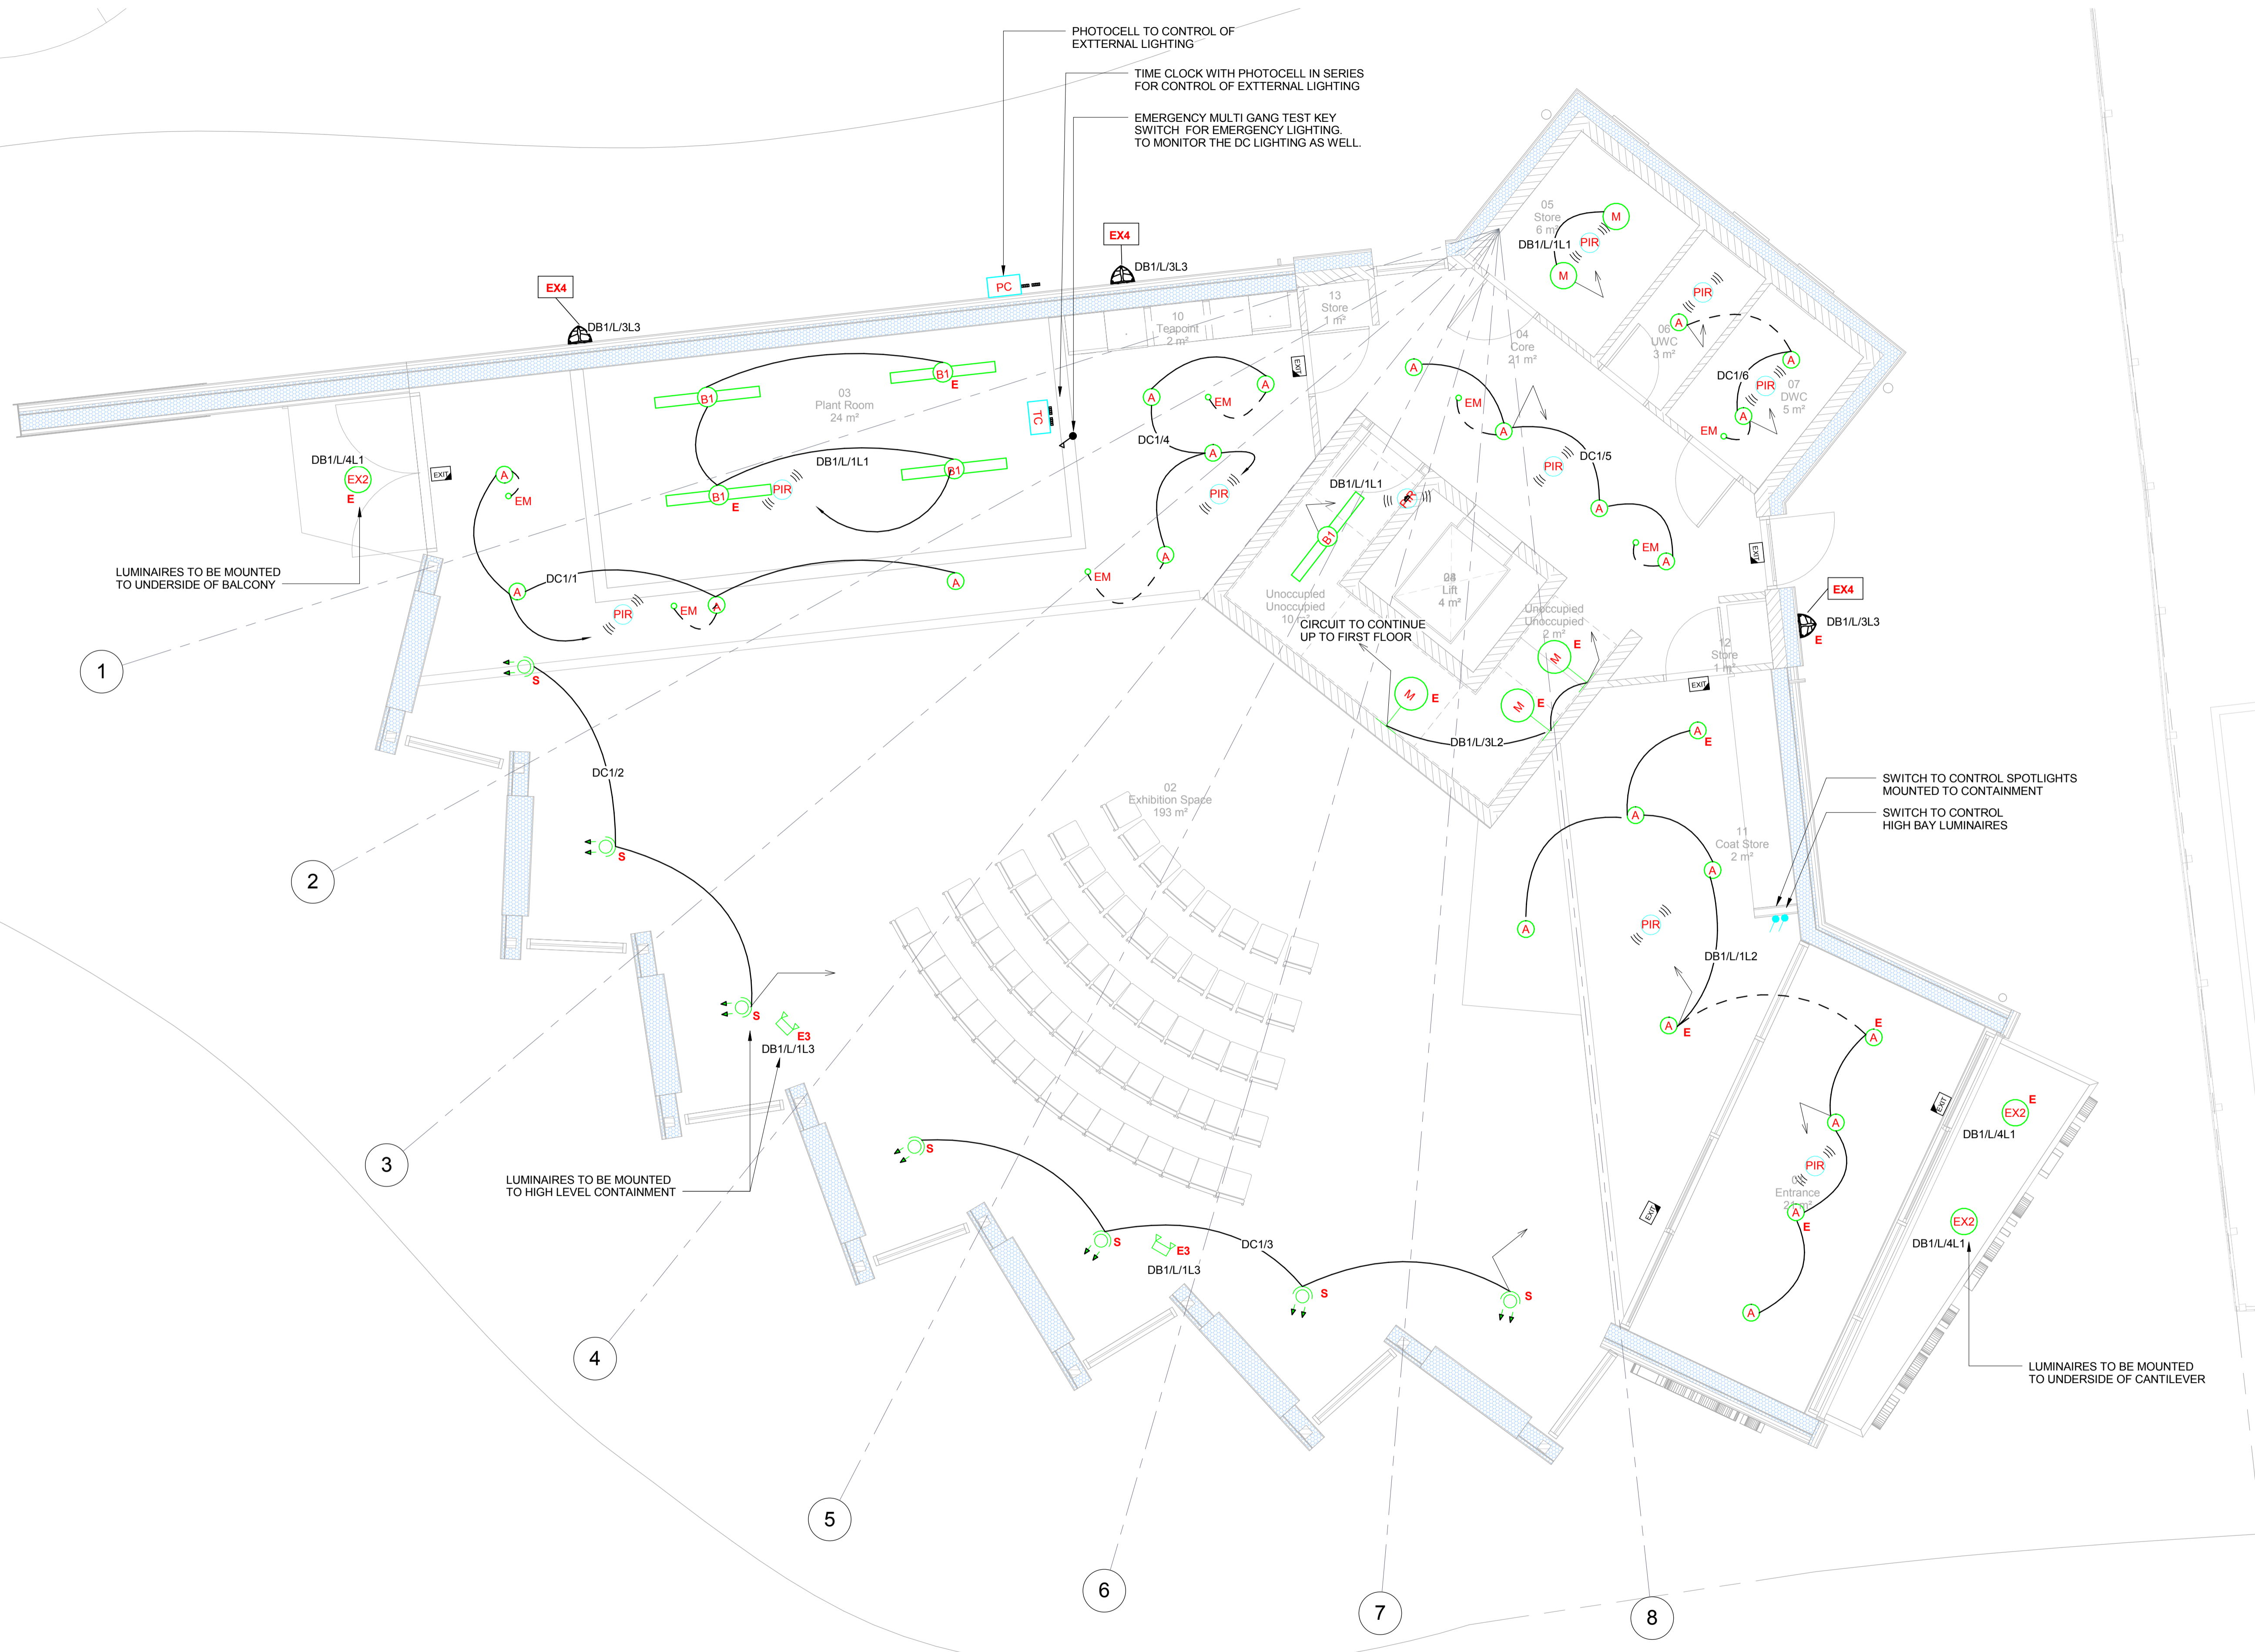

Index	Description	Drawn & Ck'd by	Rev'd by	Date
C1	CONSTRUCTION PHASE ISSUE	JT	SL	12/14

Architect:
Poynton Bradbury Wynter Cole
Atlantic Studio
Trellyn Avenue
St Ives
Cornwall TR26 2AD

Client:
Gilbert & Goode Ltd
Stennack House
Stennack Road
St Austell
Cornwall PL25 3SW



Project Title
Green Build Hub

Drawing Title
ELECTRICAL ENGINEERING SERVICES
LIGHTING LAYOUT
GROUND FLOOR

CONSTRUCTION PHASE ISSUE

Drawn by	Designed by	Reviewed by
JT	JT	SL
Project No	Date	Scale @ A1
0307549	07/17/14	1 : 50 @ A1
DRAWING NUMBER		Revision
0307579-HL-XX-00-DR-E-630-0001		C1